

DESIGNER
CWS ARCHITECTS
ARCHITECTURE | INTERIOR DESIGN
264 U.S. ROUTE ONE
BOX 6, SUITE 100-2A
SCARBOROUGH, MAINE 04074
207/774-4441
WWW.CWSARCH.COM

OWNER
PORTLAND HOUSING
AUTHORITY
14 BAYTER BLVD
PORTLAND, MAINE 04101


PROJECT
HARBOR TERRACE
ELECTRICAL UPGRADE
284 DANFORTH STREET
PORTLAND, MAINE

DRAWING
ELECTRICAL SITE PLAN
CWS PROJECT NUMBER: 21037

REVISIONS

NO.	DATE	DESCRIPTION
1.	10/21/21	ADDENDUM

DRAWING NUMBER
ES1.1
SCALE:
DATE: 08/23/2021

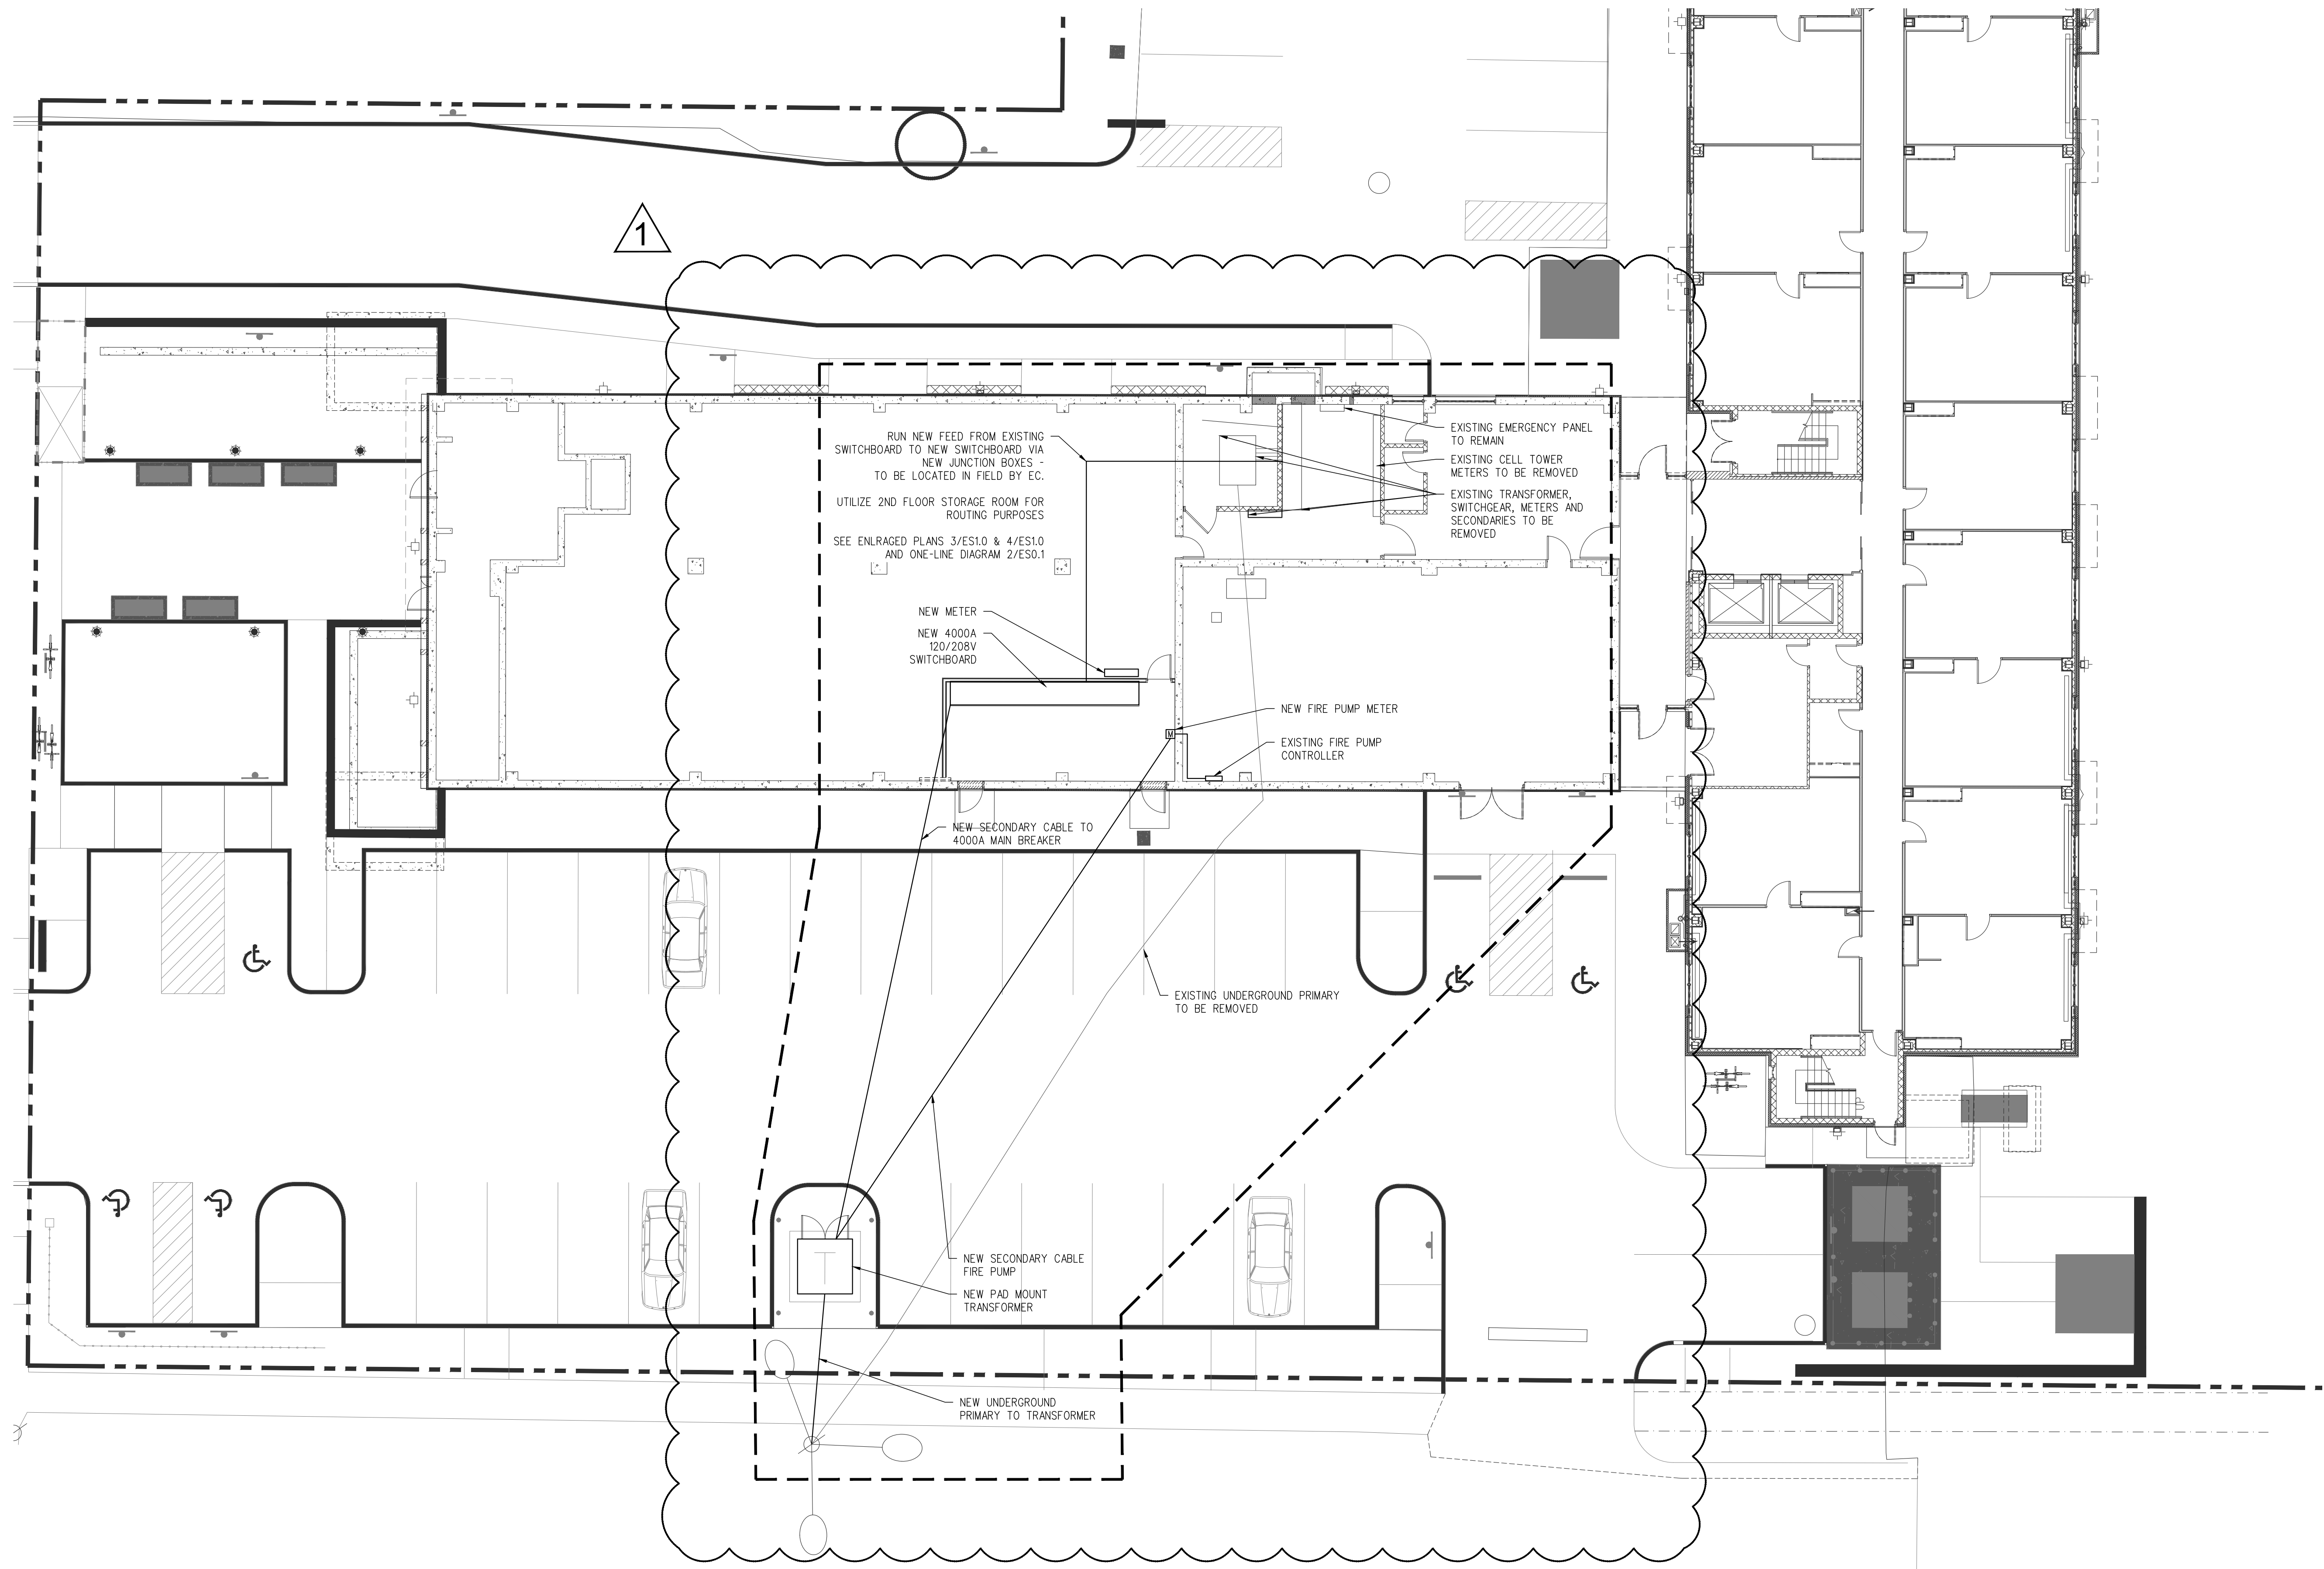

1
ES1.1
SCALE: 3/32" = 1'-0"
ELECTRICAL SITE PLAN

